



**FURNITURE VIEW A  
VIDEO CONFERENCE ROOM 106 A/V INFRASTRUCTURE**  
SCALE: 1/4"=1'-0"

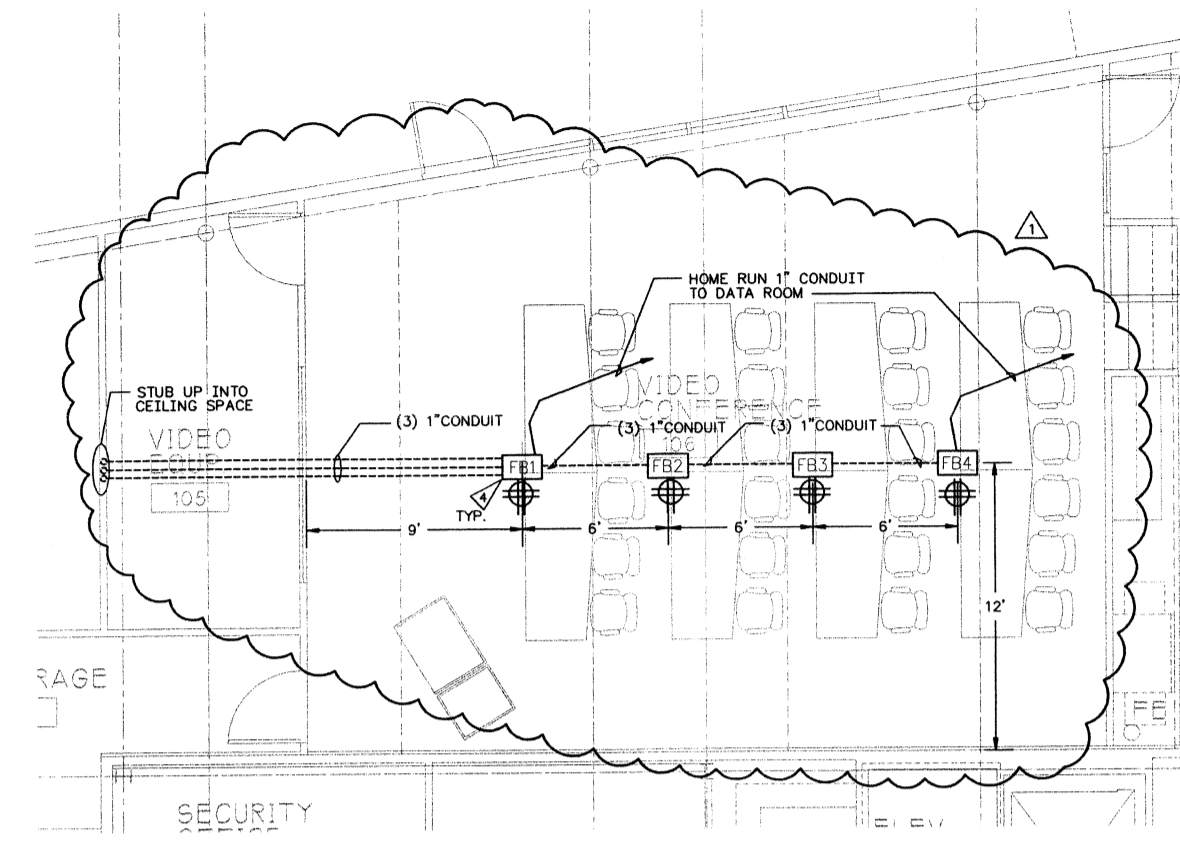

**FURNITURE VIEW B  
VIDEO CONFERENCE ROOM 106 A/V INFRASTRUCTURE**  
SCALE: 1/4"=1'-0"

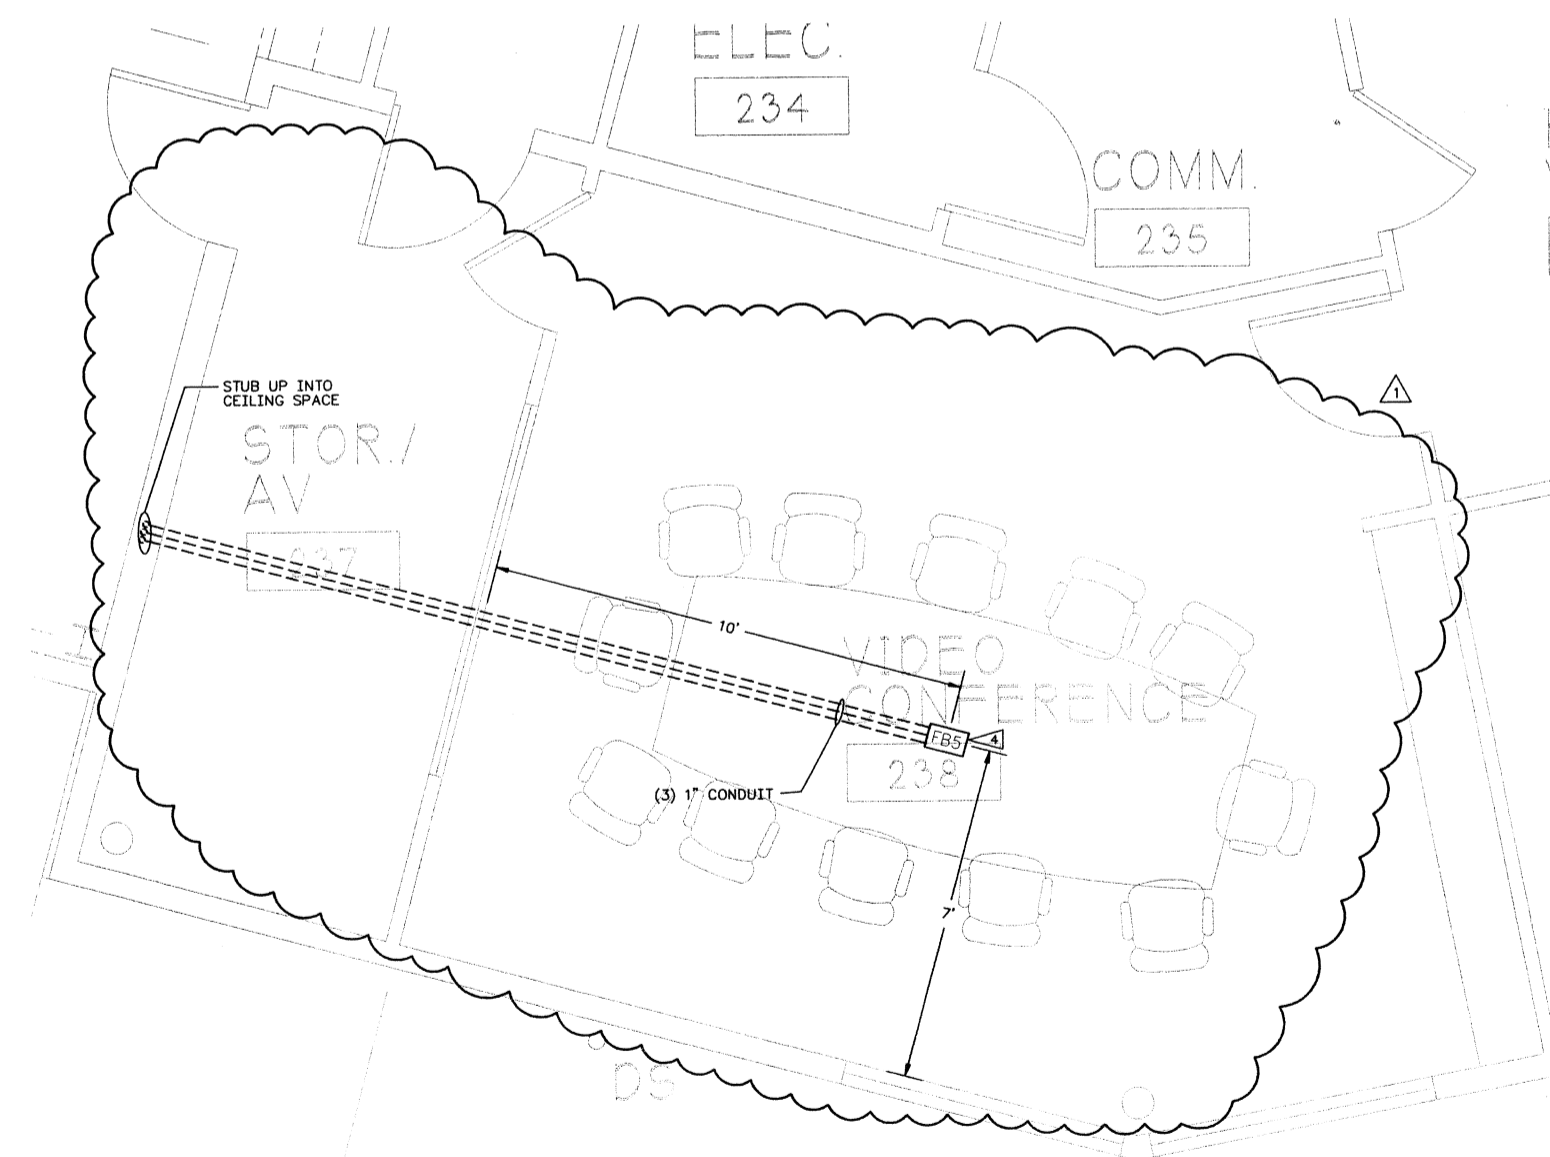

**VIDEO CONFERENCE ROOM 238 A/V INFRASTRUCTURE**  
SCALE: 1/2"=1'-0"

**FLAGNOTES:**

- COMBINE POWER/DATA/AV CONNECTIONS.

**NOTES:**

PLEASE REFER TO ARCHITECTURAL REFLECTED CEILING PLANS FOR COORDINATION WITH OTHER TRADES.