


SCALE 1/4"=1'-0"

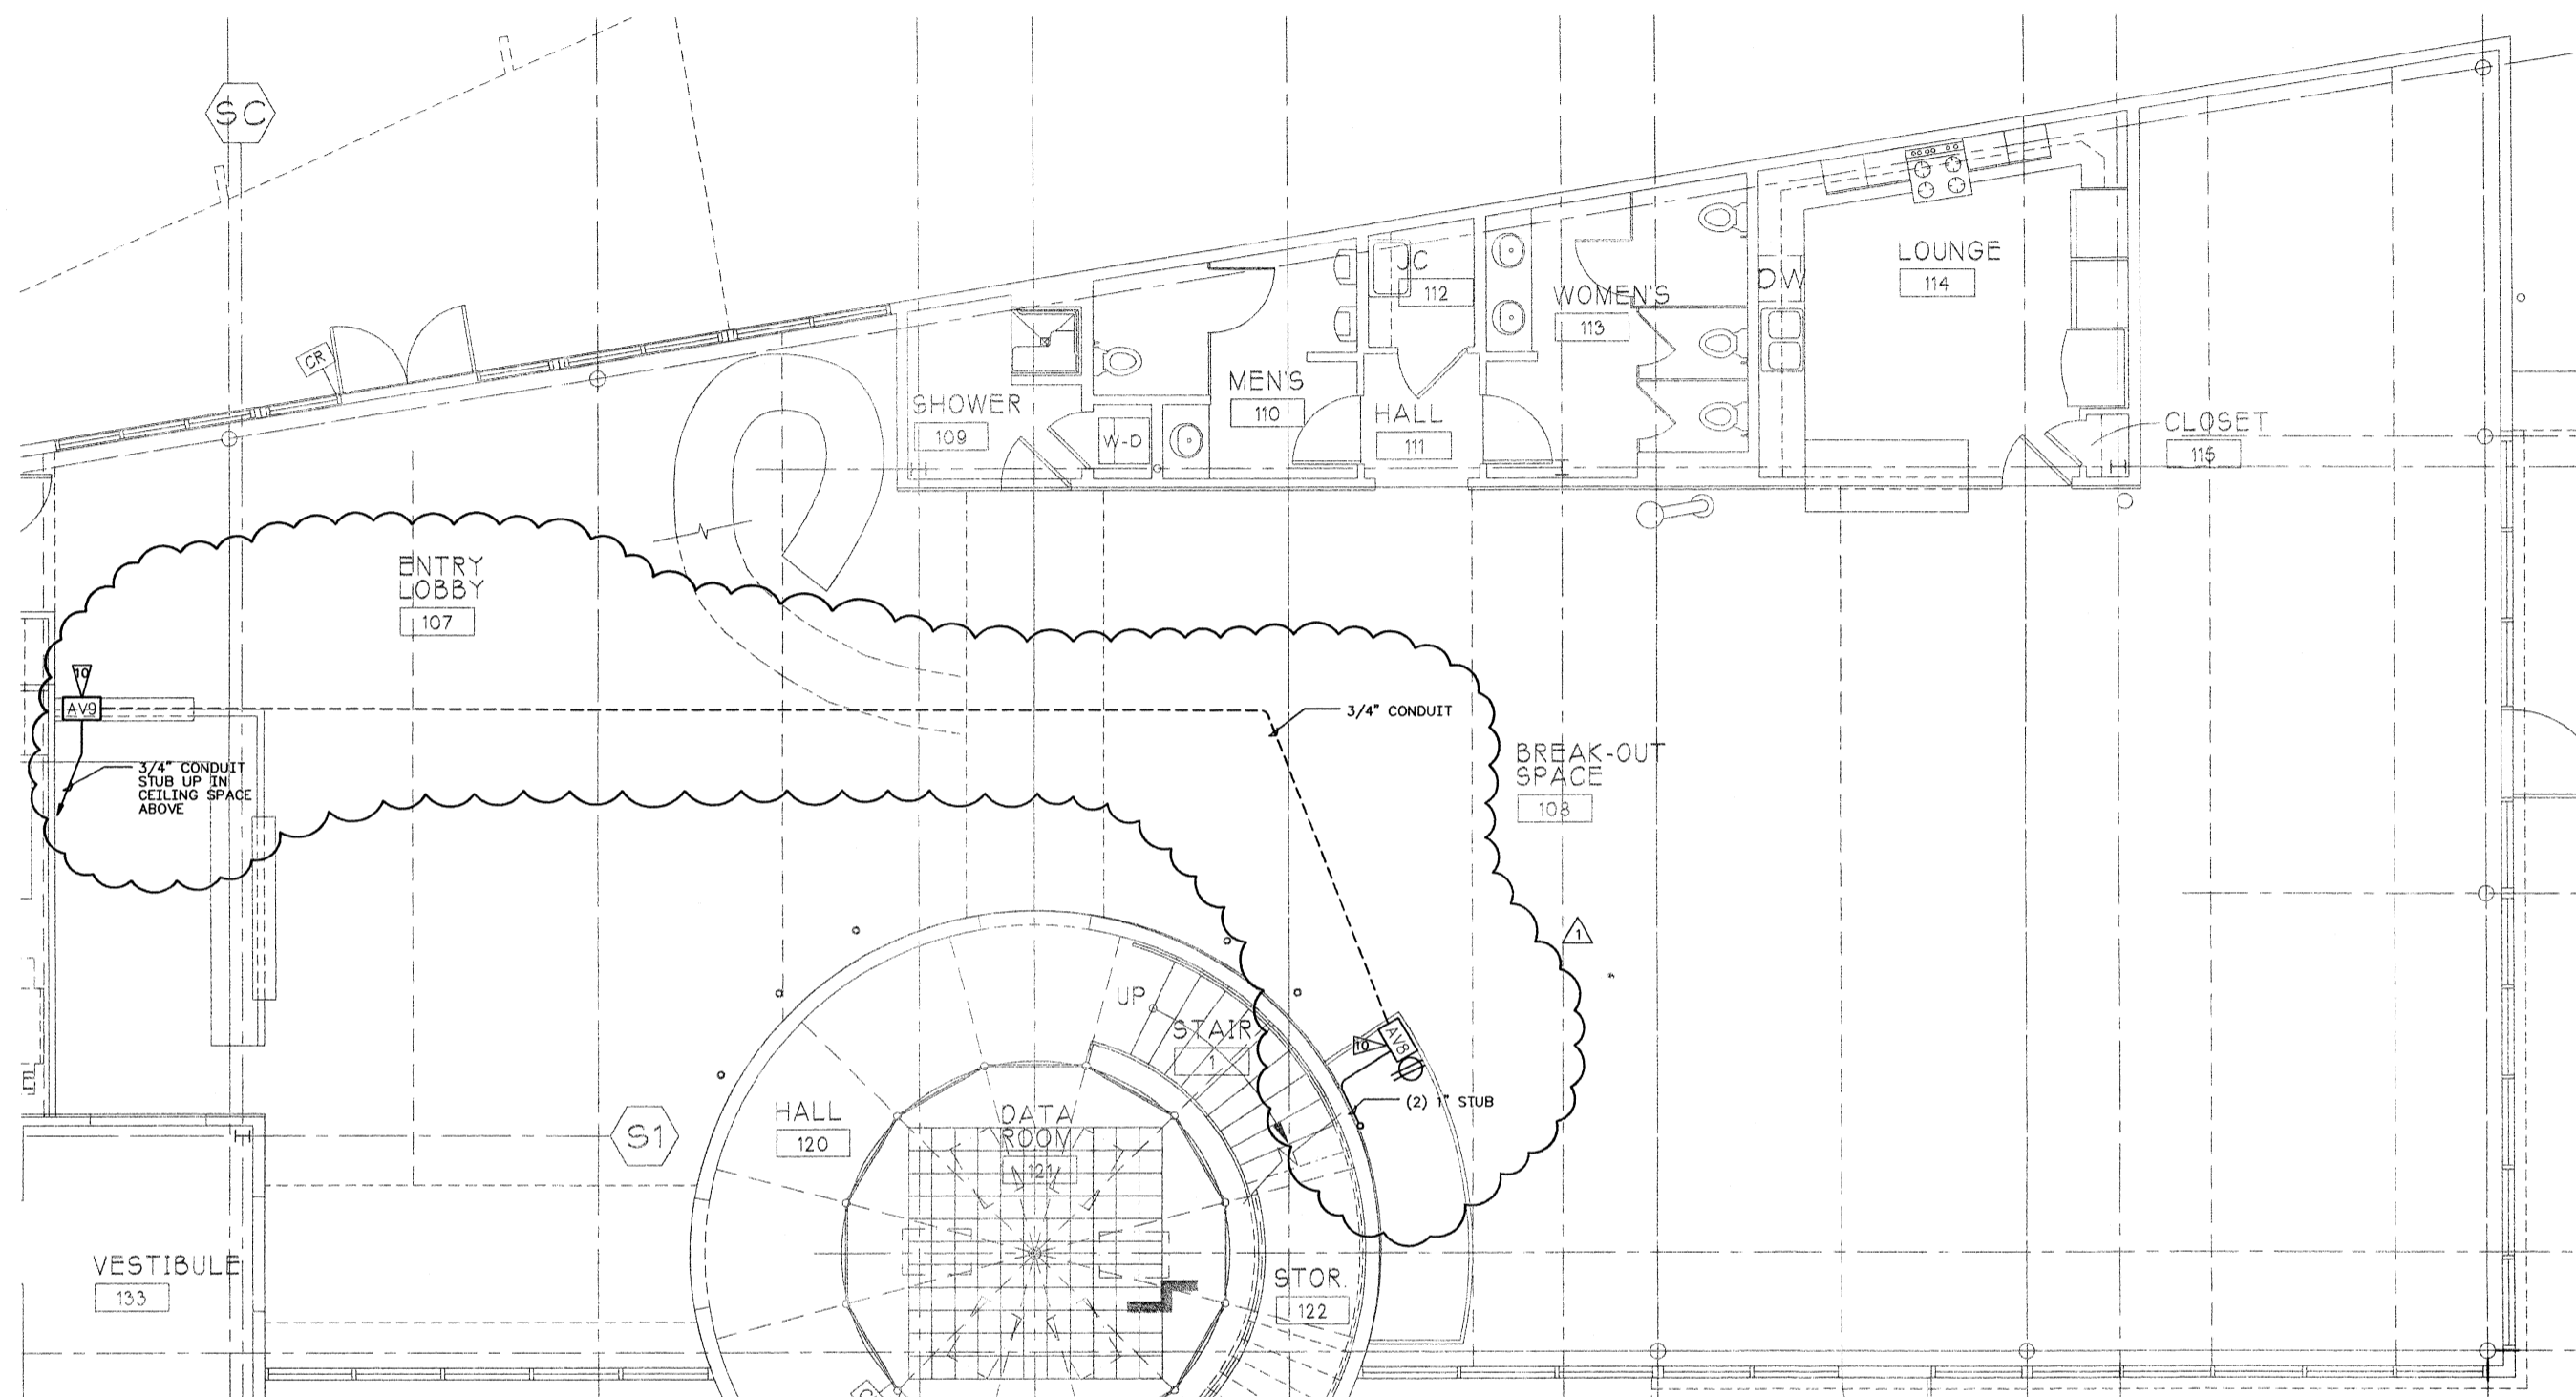

ENTRY LOBBY AND BREAKOUT SPACE A/V INFRASTRUCTURE
 SCALE: 1/4"=1'-0"

| DATE | REVISION |
|---------|------------|
| 5/18/99 | CONST. SET |

DOUG BORS
 PRINCIPAL IN CHARGE
 NATHAN THOMAS
 PROJECT MANAGER
 NATHAN THOMAS
 PROJECT ARCHITECT
 BRADY MCCOY
 DESIGNER



**LOBBY & BREAKOUT
 A/V INFRASTRUCTURE
 FLOOR PLAN**

98060
 DESIGN PROJECT NO.
 FEBRUARY 9, 1999
 DATE
 7651
 SPARLING PROJECT NO.
 1/4"=1'-0"
 SCALE

CONSTRUCTION SET **AV102**

FLAGNOTES:

4 GANG JUNCTION BOX MOUNTED IN MILLWORK. COORDINATE WITH ARCHITECTURAL DRAWINGS BEFORE ROUGH IN.

NOTES:

PLEASE REFER TO ARCHITECTURAL REFLECTED PLANS FOR COORDINATION WITH OTHER TRADES.